

No 8 TWO QUAD ABOVE DESK HEIGHT
No 3 PHONE JACK

22'-4⁹/₁₆"
F.O.S.


1 SKATE STORAGE SHED FLOOR PLAN

NOTE:

FEEDS FROM JUNCTION BOX TO 2' FLOURESCENT LIGHT FIXTURES ARE 3/8" ARMORED FLEX TWO 1" EMT FROM JUNCTION BOX TO JUNCTION BOX AT RIDGE LINE FEEDS TO RECEPTACLES IS EMT OR 1/2" ARMOR FLEX

SCALE: 1/4"=1'-0"

1. what size of conduit on drawings
2. no conduit on drawing for j boxes on ridge.
3. no telephone on desk (table) in south east corner.
4. no conduit ren of south wall (near table).
5. how do you want to switch the light over the desk (table) in the south east corner ?
6. do you need a switch for the porch light (photo operated)?
7. do we need power for the smoke detectors?
8. is there a 120v outlet on the desk(table) as shown on the drawing

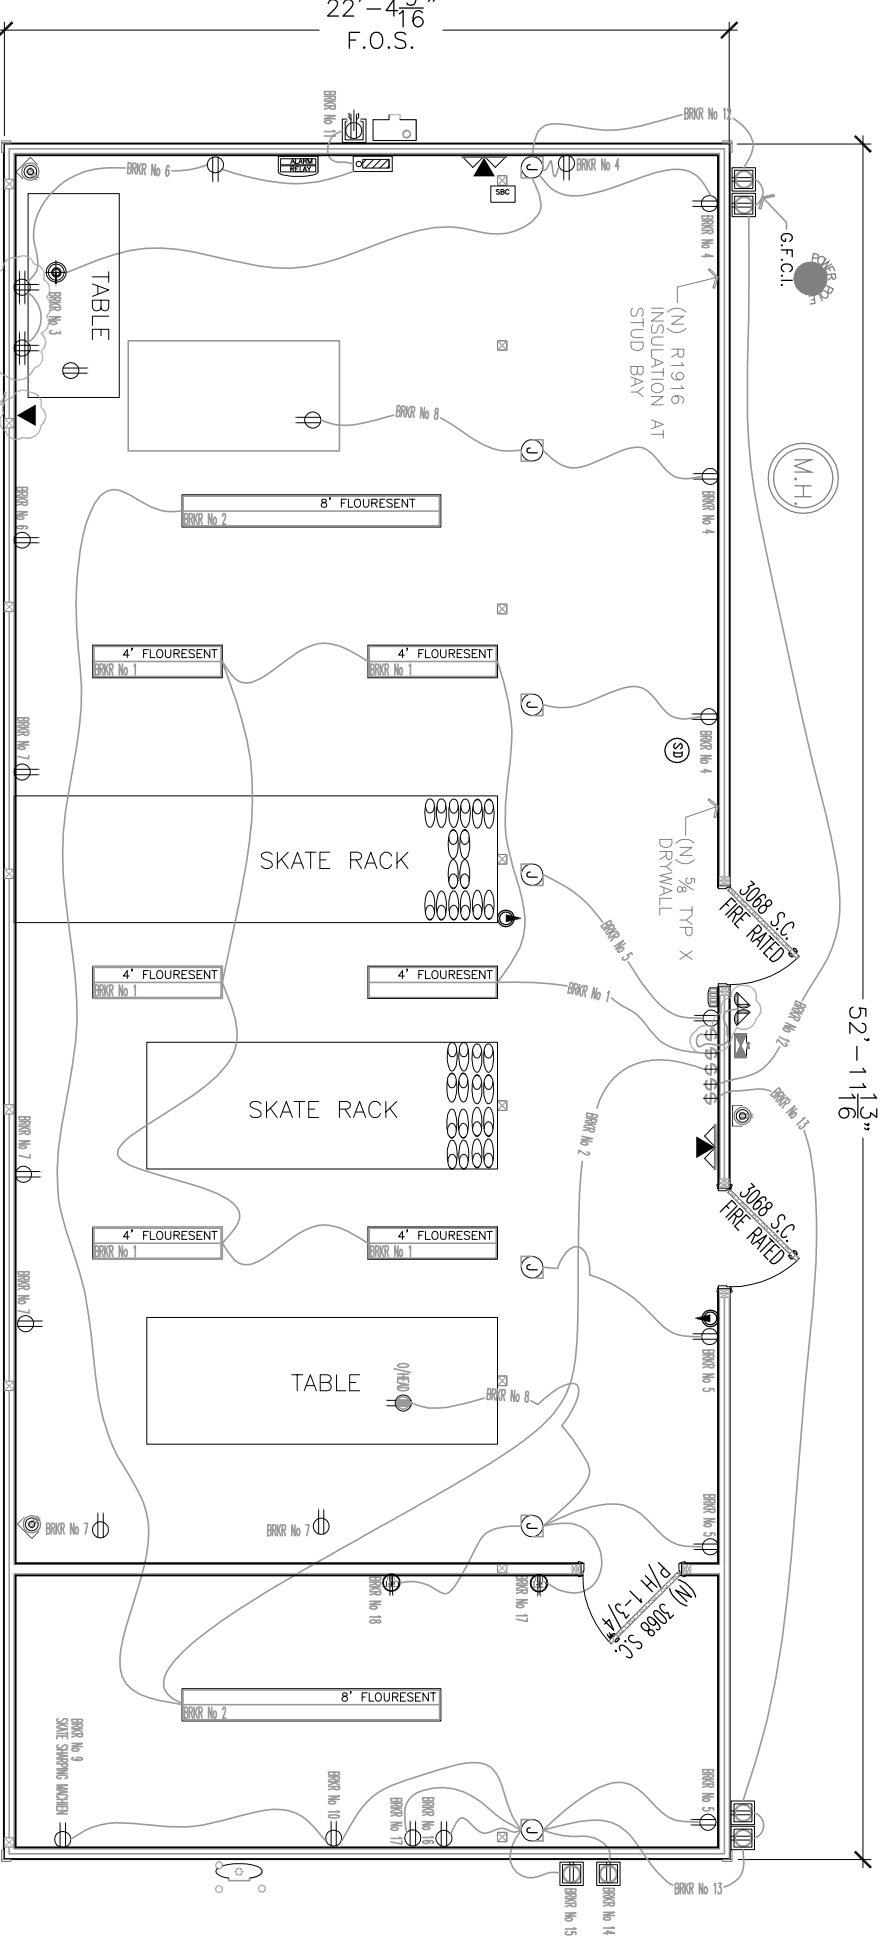

52'-11³/₁₆"